 


# Location Map



S09-0014-Greenwood Kingdom Hall  
APN(s) 074-173-03, -06 and -12



1:6,500

Prepared By:  
Gina Paolini  
Planning Services Department  
February 12, 2010

## Exhibit A


POR. SEC. 12, T.12N., R.9E. & SECS. 7 & 18, T.12N., R.10E., M.D.M.  
 GREENWOOD TOWNSITE POR. BLOCKS 1, 2, & 3

STATE HWY 193

STATE HWY 193

74:17

1" equals 100'

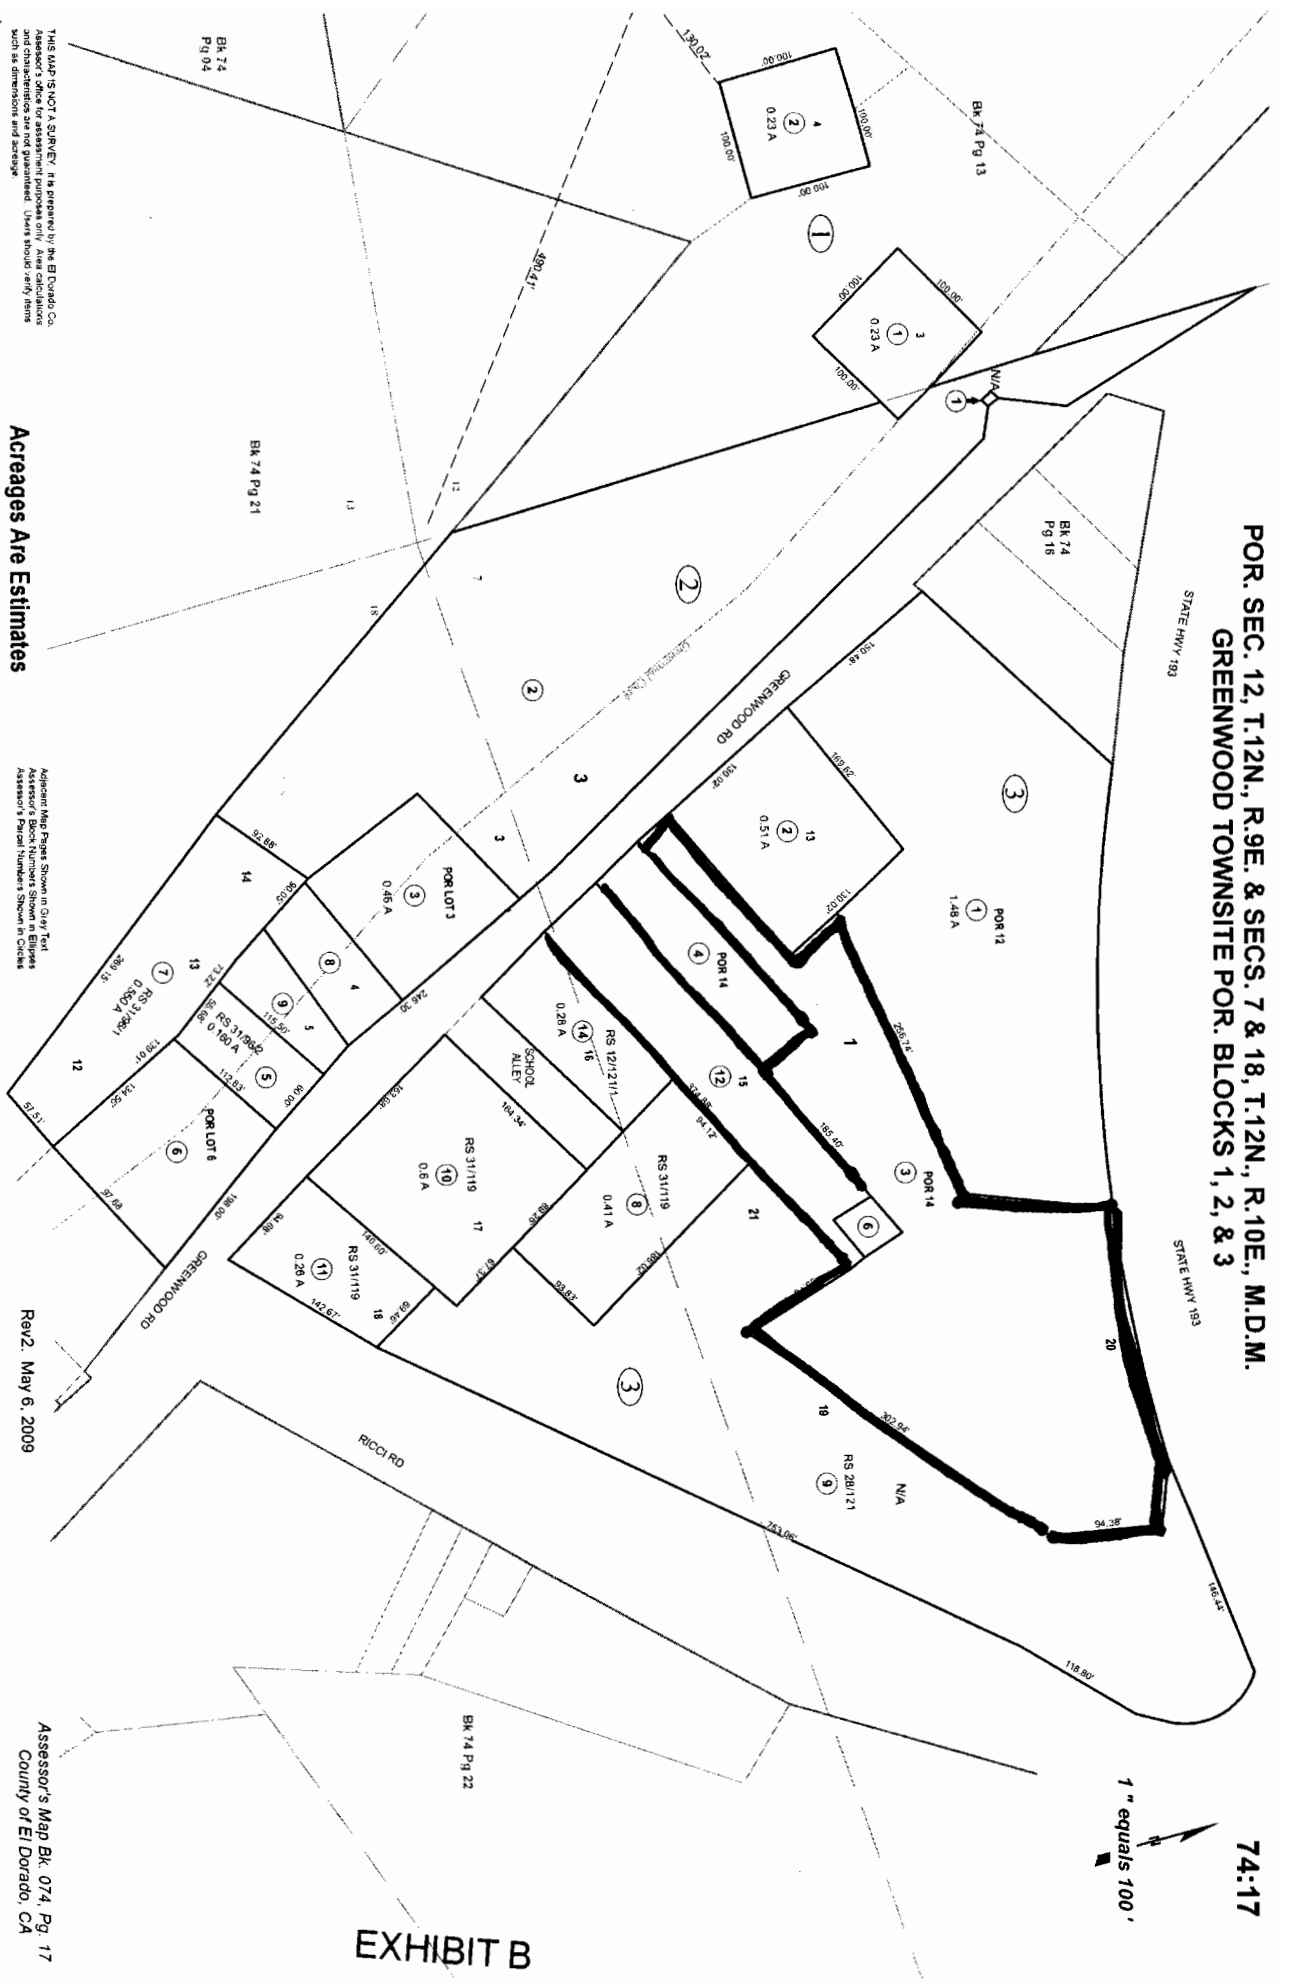

**Acreages Are Estimates**

Adjacent Map Pages Shown in Gray Text  
 Assessor's Block Numbers Shown in Ellipses  
 Assessor's Parcel Numbers Shown in Circles


Rev2, May 6, 2009

Assessor's Map Bk. 074, Pg. 17  
 County of El Dorado, CA

**EXHIBIT B**

THIS MAP IS NOT A SURVEY. It is prepared by the El Dorado Co. Assessor's office for assessment purposes only. Area calculations and characteristics are not guaranteed. Users should verify items such as dimensions and acreage.

# General Plan Map

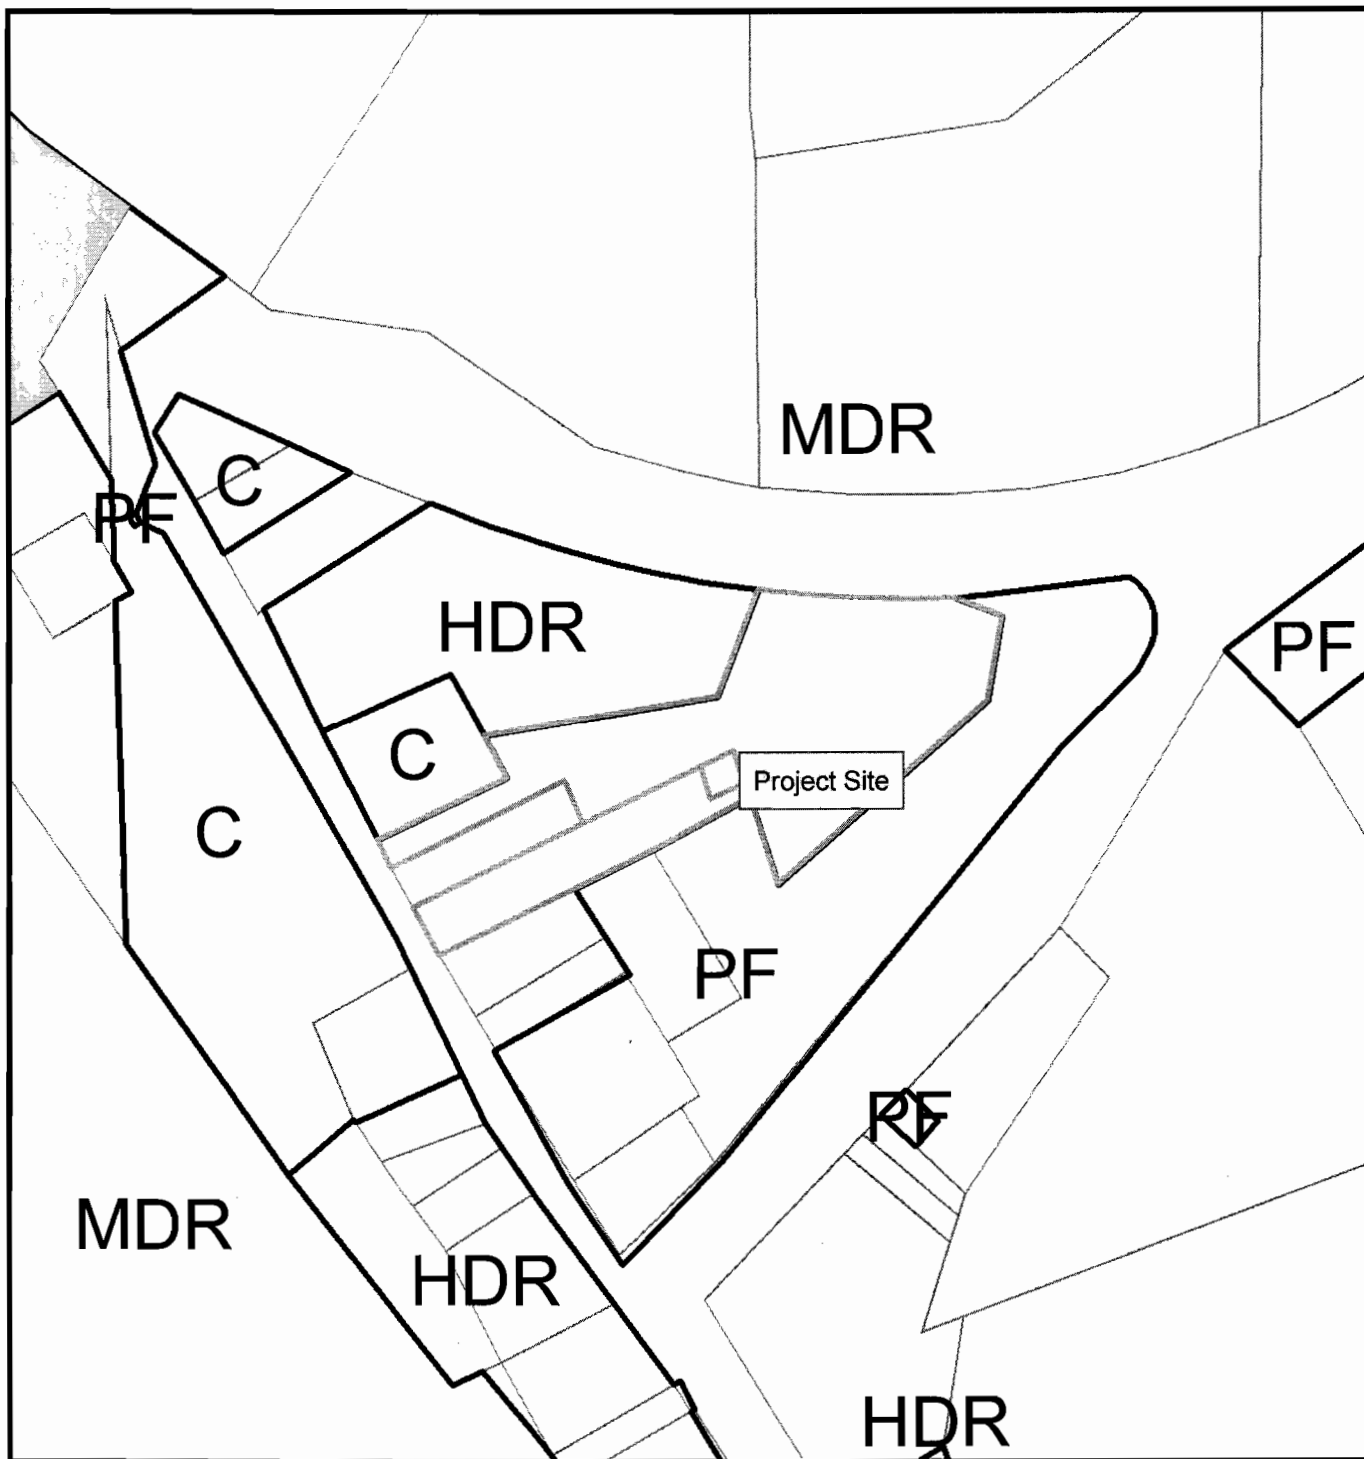


S09-0014-Greenwood Kingdom Hall  
APN(s) 074-173-03, -06 and -12

GENERAL PLAN DESIGNATION  
HDR- High Density Residential  
MDR-Medium Density Residential  
C- Commercial  
PF-Public Facility

500

1,000  
Feet


1:2,500

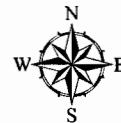

Prepared By:  
Gina Paolini  
Planning Services Department  
February 12, 2010


## Exhibit C

# Zoning Map

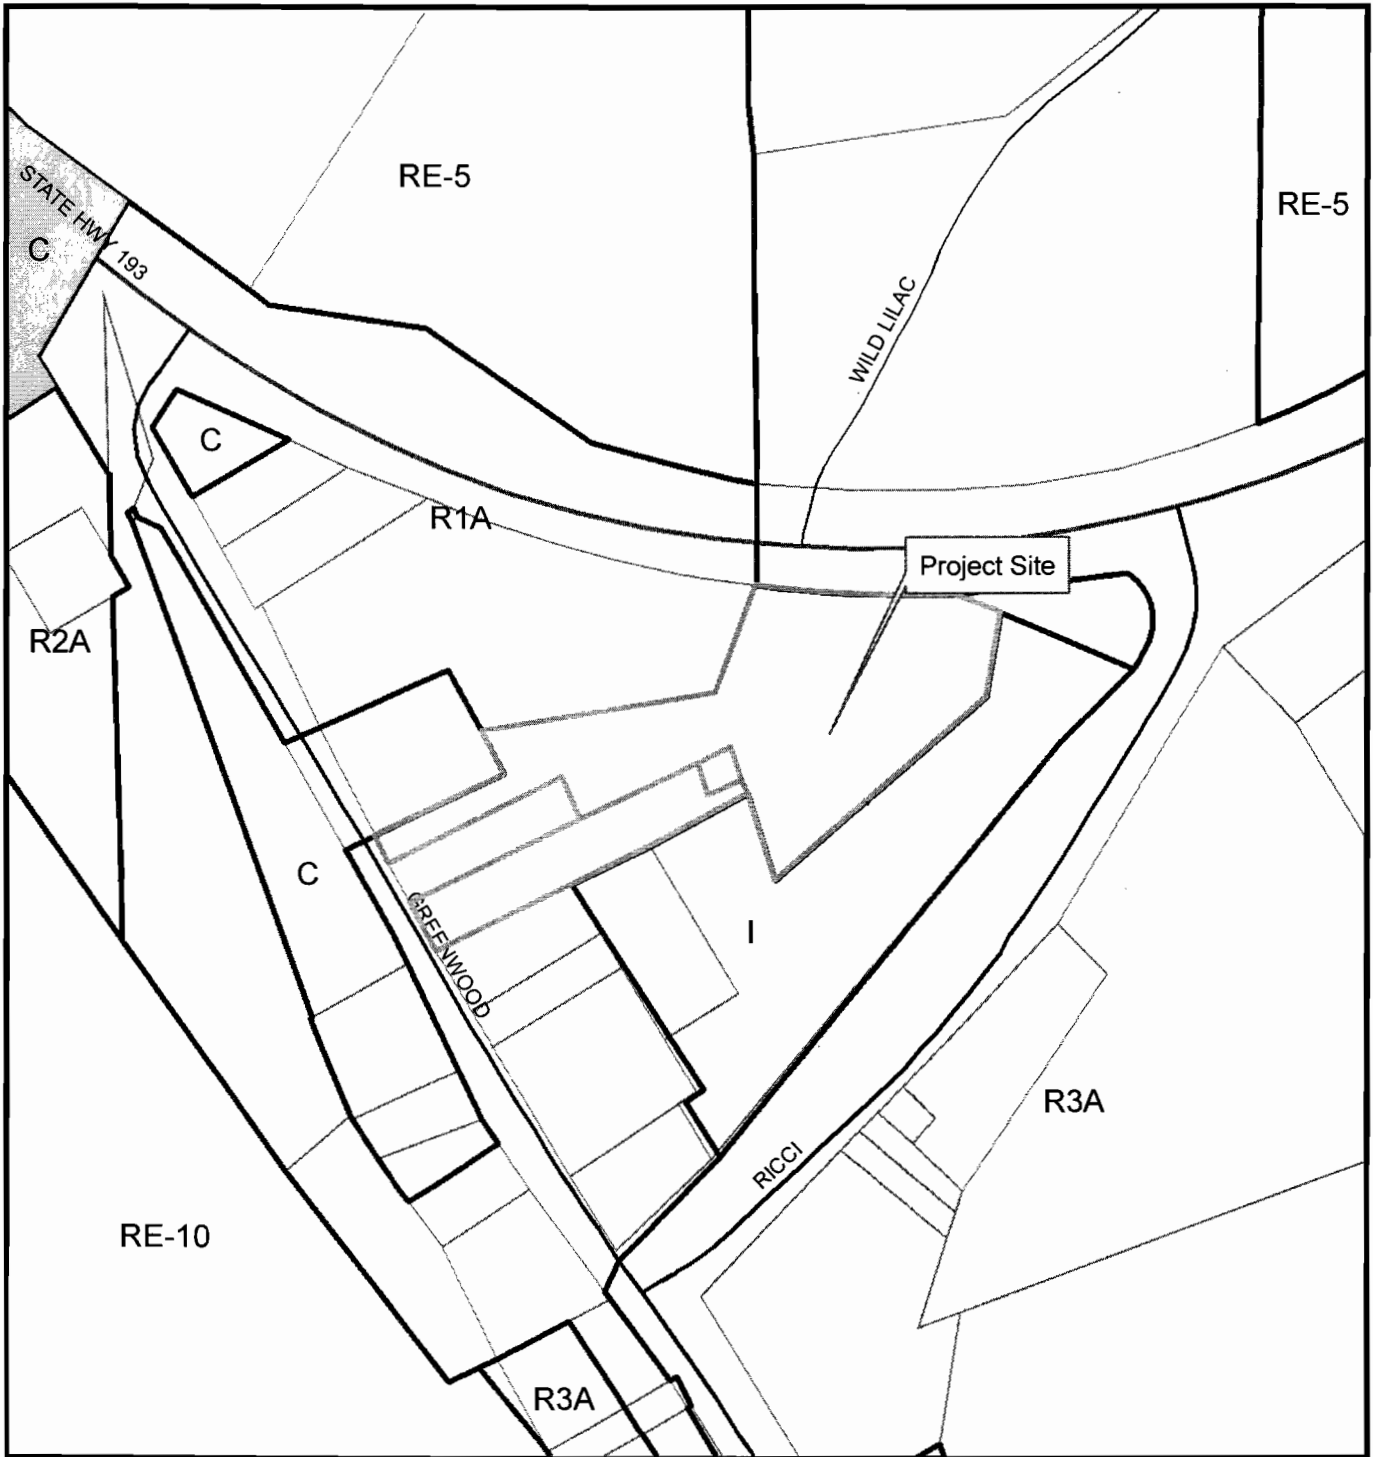

S09-0014- Greenwood Kingdom Hall  
APN(s)074-173-03, -06 and -12

 Zoning Districts  
RE-5- Estate Residential - 5 District  
R1A - One-Acre Residential District  
C - Commercial District  
I- Industrial District



1:2,500



Prepared By:  
Gina Paolini  
Planning Services Department  
February 12, 2010

**Exhibit D**



RECEIVED  
PLANNING DEPARTMENT





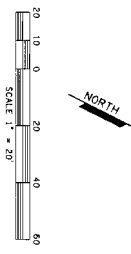


EXHIBIT F

PREPARED BY WONG & ASSOCIATES ENGINEERING & SURVEYING - LAND PLANNING 5720 AVENUE WAY, SUITE 212 SAN JOSE, CALIFORNIA 95128 TEL: (415) 281-4800 FAX: (415) 281-4899	DRAWN BY J. WONG	CHECKED BY J. WONG	DATE 7-20-2000
PROJECT PRELIMINARY GRADING PLAN OF APN 074-173-03, 074-173-06, AND 074-173-12 GEORGETOWN KINGDOM HALL STATE OF CALIFORNIA	SHEET 1 OF 2		

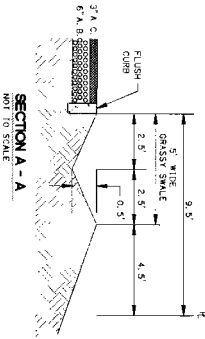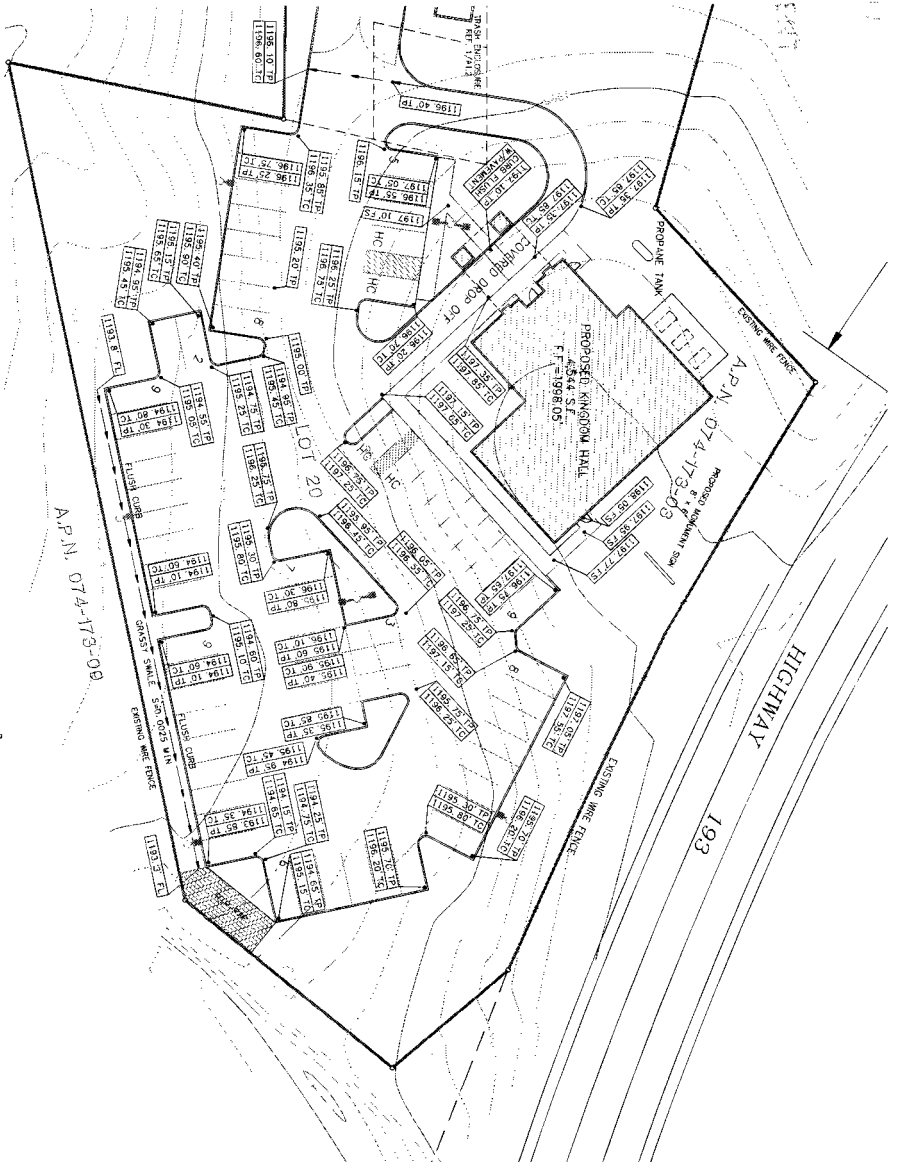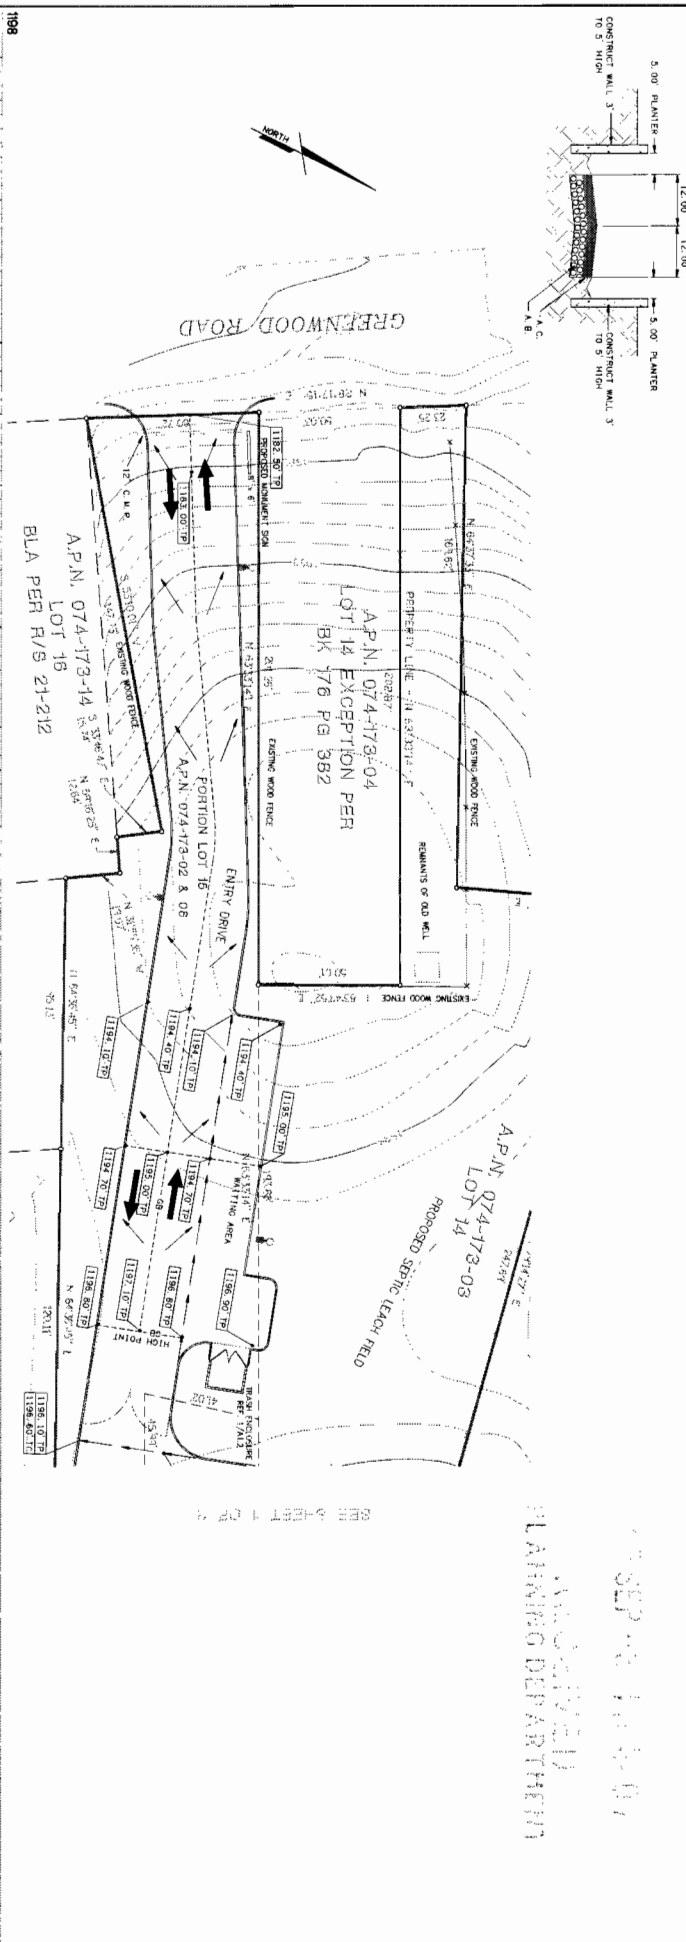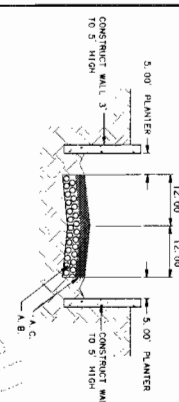

RECEIVED  
PLANNING DEPARTMENT

PROPOSER: [ ]  
SCALE: [ ]

**WONG & ASSOCIATES**  
ENGINEERING & LAND PLANNING  
2210 ARDEN WAY, SUITE 212  
SAN JOSE, CA 95128  
TEL: (415) 281-4600 FAX: (415) 281-4609

DESIGNED BY: [ ]  
DRAWN BY: [ ]  
CHECKED BY: [ ]  
SCALE: [ ]

NO.	DATE	REVISION



**PRELIMINARY GRADING PLAN**  
OF  
APNs 074-173-03, 074-173-06, AND 074-173-12  
GEORGETOWN KINNDOM HALL  
STATE OF CALIFORNIA

DATE: 7-20-2007  
SHEET: 2 OF 2

DATE: 10/15/07  
 DRAWN BY: J. L. LYNN  
 CHECKED BY: J. L. LYNN  
 PROJECT NUMBER: 06-010  
 REVISIONS:

- NOTES**
1. ALL PLANTER AREAS TO BE TREATED WITH PREEMERGENT HERBICIDE AS PER MANUFACTURER'S RECOMMENDATIONS.
  2. ALL PLANTER AREAS TO BE COVERED WITH 3 INCHES MINIMUM GRANULAR MULCH.
  3. ALL TREES TO BE DOUBLE STAKED.
  4. ALL PLANT MATERIAL TO BE FERTILIZED AT TIME OF PLANTING WITH APPLICATOR PLANT TAGS AS PER MANUFACTURER'S RECOMMENDATIONS.
  5. IRRIGATION SYSTEM TO BE UNDERGROUND DRIP SYSTEM WITH TIME CLOCK CONTROL.

**TREE LEGEND**

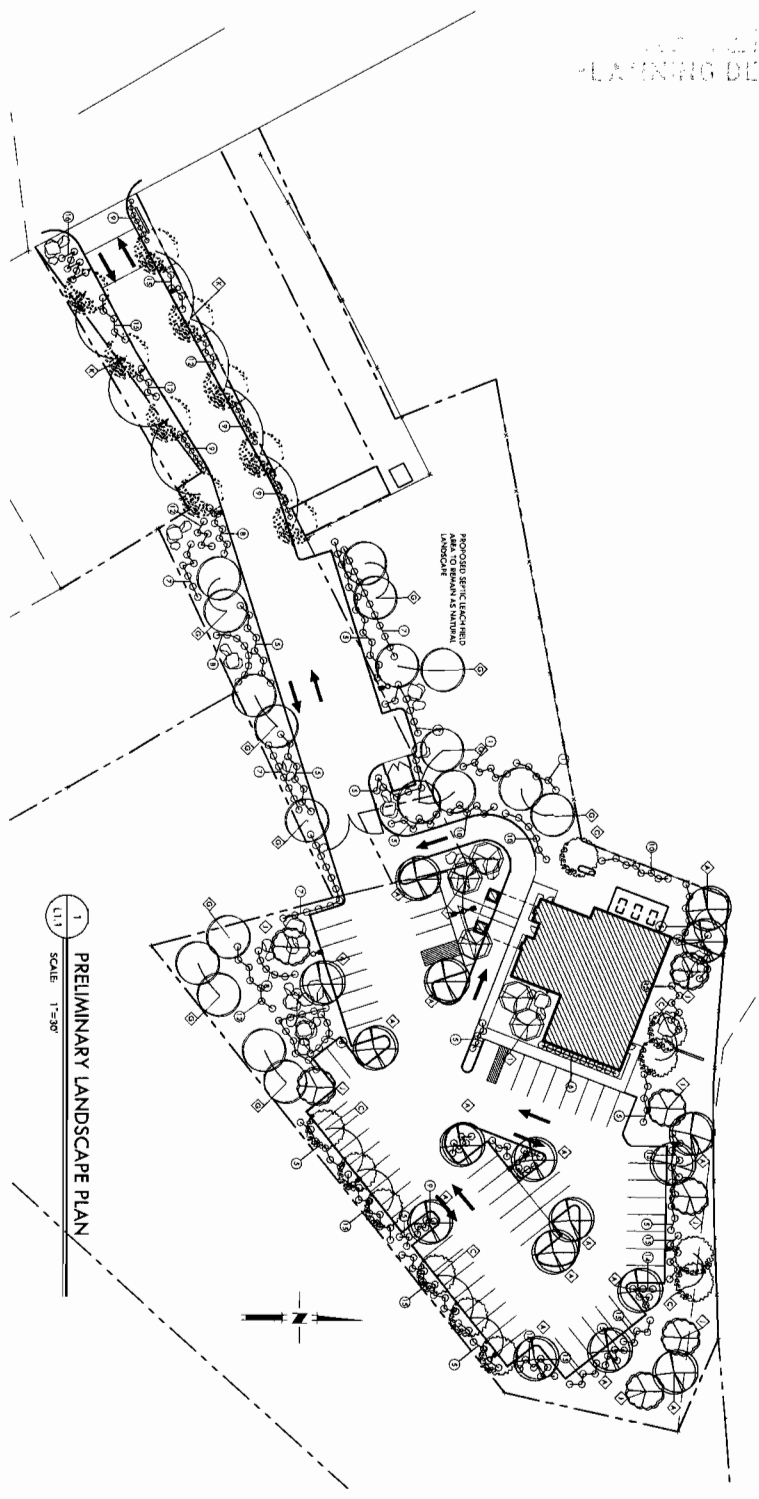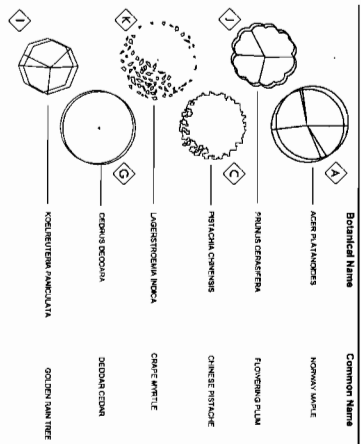

1 PRELIMINARY LANDSCAPE PLAN  
 SCALE: 1"=30'

**PLANT SCHEDULE**

ID	Size	Qty.	Botanical Name	Common Name	Water Use
1	3.0m	10	ACER PLATANIFOLIOS	CHERRY BLOSSOM	L
2	3.0m	10	LABURNUM ANagyria	SECOYIA CEDAR	L
3	3.0m	10	LABURNUM ANagyria	CHERRY WHITE	L
4	3.0m	10	LABURNUM ANagyria	CHERRY PRUNO	L
5	3.0m	10	LABURNUM ANagyria	FLOWERING PLUM	L
6	3.0m	10	LABURNUM ANagyria	GOLDEN RAIN TREE	L
7	3.0m	10	LABURNUM ANagyria	CHERRY WHITE	L
8	3.0m	10	LABURNUM ANagyria	CHERRY PRUNO	L
9	3.0m	10	LABURNUM ANagyria	FLOWERING PLUM	L
10	3.0m	10	LABURNUM ANagyria	GOLDEN RAIN TREE	L
11	3.0m	10	LABURNUM ANagyria	CHERRY WHITE	L
12	3.0m	10	LABURNUM ANagyria	CHERRY PRUNO	L
13	3.0m	10	LABURNUM ANagyria	FLOWERING PLUM	L
14	3.0m	10	LABURNUM ANagyria	GOLDEN RAIN TREE	L
15	3.0m	10	LABURNUM ANagyria	CHERRY WHITE	L
16	3.0m	10	LABURNUM ANagyria	CHERRY PRUNO	L
17	3.0m	10	LABURNUM ANagyria	FLOWERING PLUM	L
18	3.0m	10	LABURNUM ANagyria	GOLDEN RAIN TREE	L
19	3.0m	10	LABURNUM ANagyria	CHERRY WHITE	L
20	3.0m	10	LABURNUM ANagyria	CHERRY PRUNO	L
21	3.0m	10	LABURNUM ANagyria	FLOWERING PLUM	L
22	3.0m	10	LABURNUM ANagyria	GOLDEN RAIN TREE	L
23	3.0m	10	LABURNUM ANagyria	CHERRY WHITE	L
24	3.0m	10	LABURNUM ANagyria	CHERRY PRUNO	L
25	3.0m	10	LABURNUM ANagyria	FLOWERING PLUM	L
26	3.0m	10	LABURNUM ANagyria	GOLDEN RAIN TREE	L
27	3.0m	10	LABURNUM ANagyria	CHERRY WHITE	L
28	3.0m	10	LABURNUM ANagyria	CHERRY PRUNO	L
29	3.0m	10	LABURNUM ANagyria	FLOWERING PLUM	L
30	3.0m	10	LABURNUM ANagyria	GOLDEN RAIN TREE	L
31	3.0m	10	LABURNUM ANagyria	CHERRY WHITE	L
32	3.0m	10	LABURNUM ANagyria	CHERRY PRUNO	L
33	3.0m	10	LABURNUM ANagyria	FLOWERING PLUM	L
34	3.0m	10	LABURNUM ANagyria	GOLDEN RAIN TREE	L
35	3.0m	10	LABURNUM ANagyria	CHERRY WHITE	L
36	3.0m	10	LABURNUM ANagyria	CHERRY PRUNO	L
37	3.0m	10	LABURNUM ANagyria	FLOWERING PLUM	L
38	3.0m	10	LABURNUM ANagyria	GOLDEN RAIN TREE	L
39	3.0m	10	LABURNUM ANagyria	CHERRY WHITE	L
40	3.0m	10	LABURNUM ANagyria	CHERRY PRUNO	L
41	3.0m	10	LABURNUM ANagyria	FLOWERING PLUM	L
42	3.0m	10	LABURNUM ANagyria	GOLDEN RAIN TREE	L
43	3.0m	10	LABURNUM ANagyria	CHERRY WHITE	L
44	3.0m	10	LABURNUM ANagyria	CHERRY PRUNO	L
45	3.0m	10	LABURNUM ANagyria	FLOWERING PLUM	L
46	3.0m	10	LABURNUM ANagyria	GOLDEN RAIN TREE	L
47	3.0m	10	LABURNUM ANagyria	CHERRY WHITE	L
48	3.0m	10	LABURNUM ANagyria	CHERRY PRUNO	L
49	3.0m	10	LABURNUM ANagyria	FLOWERING PLUM	L
50	3.0m	10	LABURNUM ANagyria	GOLDEN RAIN TREE	L

ISSUE DATE: 10/15/07  
 CHECKED BY: J. L. LYNN  
 DRAWN BY: J. L. LYNN  
 PROJECT NUMBER: 06-010  
 REVISIONS:


**SHEET TITLE:**  
 PRELIMINARY LANDSCAPE PLAN

**PROJECT TITLE:**  
 GEORGETOWN KINGDOM HALL  
 HWY 193 & RICCI ROAD  
 GREENWOOD, CALIFORNIA

**EXHIBIT G**



DATE: 11.10.07  
 DRAWN BY: LYNN  
 CHECKED BY: LYNN  
 PROJECT NUMBER: 06-01  
 REVISIONS:  
 PLANNING DEPARTMENT

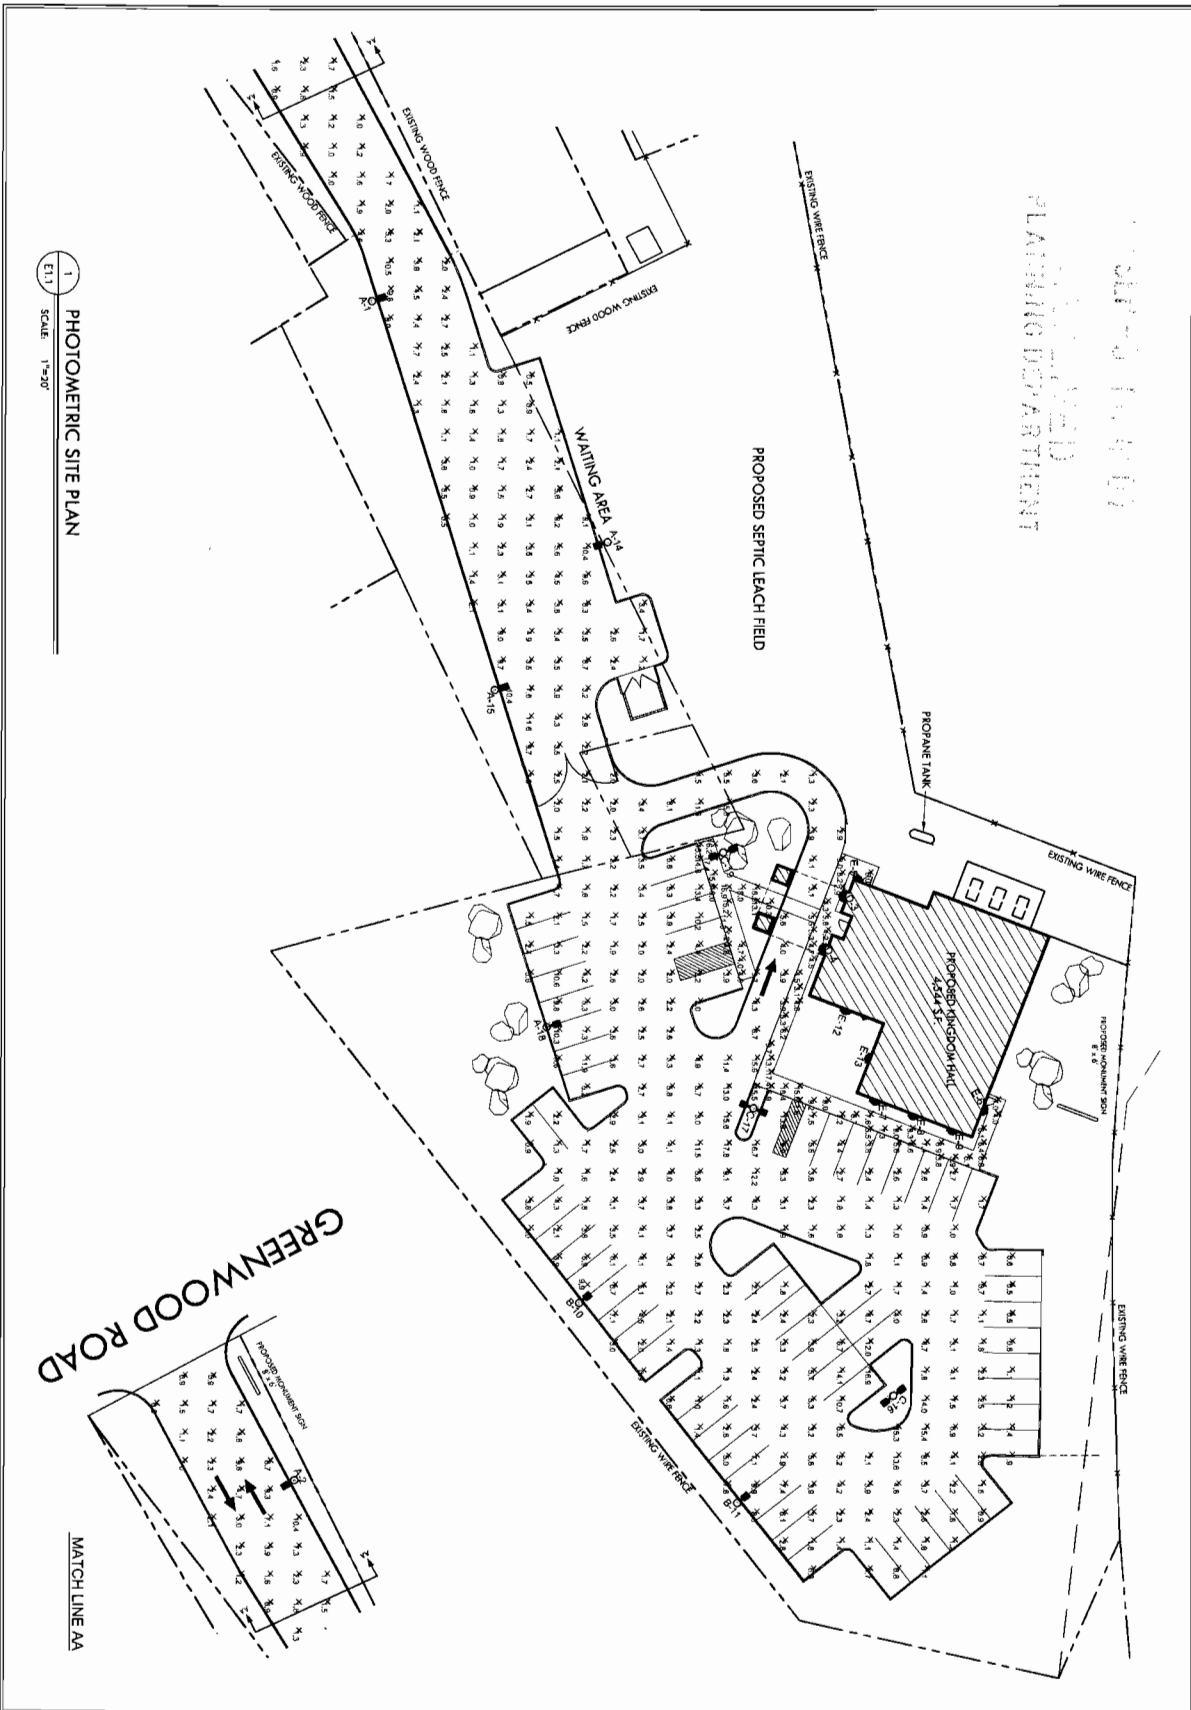

1  
 ET11  
 SCALE: 1"=20'

GREENWOOD ROAD

MATCH LINE AA

ISSUE DATE: 8.15.06 CHECKED BY: LYNN DRAWN BY: LYNN PROJECT NUMBER: 06-01 REVISIONS: 1 2 3 1446 
---

STATISTICS						
Description	Symbol	Avg	Max	Min	Max/min	Avg/min
SITE	+	3.9 ft	17.8 ft	0.3 ft	38.8:1	7.8:1
WALKWAY	+	8.9 ft	18.5 ft	2.8 ft	8:1	3:1

LUMINAIRE SCHEDULE								
Symbol	Qty	Catalog Number	Description	Lamp	Flux	Lumens / LF	Watts	
□	5	K40 400M R3	Area Luminaire, 400W K40 400M R3 CLEAR BETA PHASE START METAL HALIDE LAMP IN HORIZONTAL POSITION CRITERIA	ONE (1) 400 WATT CLEAR BETA PHASE START METAL HALIDE LAMP IN HORIZONTAL POSITION	K40_400M_R3 -1.1m	42000	0.72	468
□	2	K40 400M R4	Area Luminaire, 400W K40 400M R4 BETA PHASE START METAL HALIDE LAMP IN HORIZONTAL POSITION CRITERIA	ONE (1) 400 WATT BETA PHASE START METAL HALIDE LAMP IN HORIZONTAL POSITION	K40_400M_R4 -1.1m	38000	0.72	468
□	3	K40 400M R3	Area Luminaire, 400W K40 400M R3 CLEAR BETA PHASE START METAL HALIDE LAMP IN HORIZONTAL POSITION CRITERIA	ONE (1) 400 WATT CLEAR BETA PHASE START METAL HALIDE LAMP IN HORIZONTAL POSITION	K40_400M_R3 -1.1m	42000	0.72	812
□	2	TVA 50M	GENERAL PURPOSE RECURRING MOUNTED LUMINAIRE, 50W/MH, W/ CLEAR LAMP	ONE (1) 50 WATT CLEAR BETA PHASE START METAL HALIDE LAMP IN HORIZONTAL POSITION	TVA_50M	3500	0.72	72
□	7	TVA 100M	GENERAL PURPOSE RECURRING MOUNTED LUMINAIRE, 100W/MH, W/ CLEAR LAMP	ONE (1) 100 WATT CLEAR BETA PHASE START METAL HALIDE LAMP IN HORIZONTAL POSITION	TVA_100M	8000	0.72	140

LUMINAIRE LOCATIONS							
No.	Label	X	Y	Z	MH	Obstruction	TM
1	A	282.7	414.8	20.0	20.0	-16.7	0.0
2	A	145.4	399.5	20.0	20.0	150.4	0.0
3	D	471.6	581.3	8.0	8.0	202.0	0.0
4	D	480.2	574.2	8.0	8.0	202.0	0.0
5	E	483.8	590.8	8.0	8.0	-99.0	0.0
6	E	547.1	611.1	8.0	8.0	21.1	0.0
7	E	544.0	592.8	10.0	10.0	111.0	0.0
8	E	548.2	606.2	10.0	10.0	111.0	0.0
9	E	554.4	619.5	10.0	10.0	111.0	0.0
10	B	614.5	489.2	20.0	20.0	-38.4	0.0
11	B	605.3	544.1	20.0	20.0	-38.4	0.0
12	E	512.1	582.1	10.0	10.0	111.0	0.0
13	E	528.7	590.2	10.0	10.0	201.0	0.0
14	A	547.2	486.0	20.0	20.0	161.8	0.0
15	A	396.2	456.2	20.0	20.0	-15.0	0.0
16	C	647.6	599.1	20.0	20.0	-38.4	0.0
17	C	548.3	549.9	20.0	20.0	21.0	0.0
18	A	517.6	478.8	20.0	20.0	-17.8	0.0
19	C	458.7	538.9	20.0	20.0	162.4	0.0

1  
AXX  
SCALE: 1"=30'


PHOTOMETRIC LAMP DATA SCHEDULE

ISSUE DATE: 8.1.2009  
 CHECKED BY: LYNN  
 DRAWN BY:  
 PROJECT NUMBER: 09-01  
 REVISIONS:  
 SHEET NUMBER: B1.2

SHEET TITLE:  
**PHOTOMETRIC LAMP  
 DATA SCHEDULE**

PROJECT TITLE:  
**GEORGETOWN  
 KINGDOM HALL**  
 HWY 193 & RICCI ROAD  
 GREENWOOD, CALIFORNIA

UNIVERSITY OF CALIFORNIA  
 PLANNING DEPARTMENT

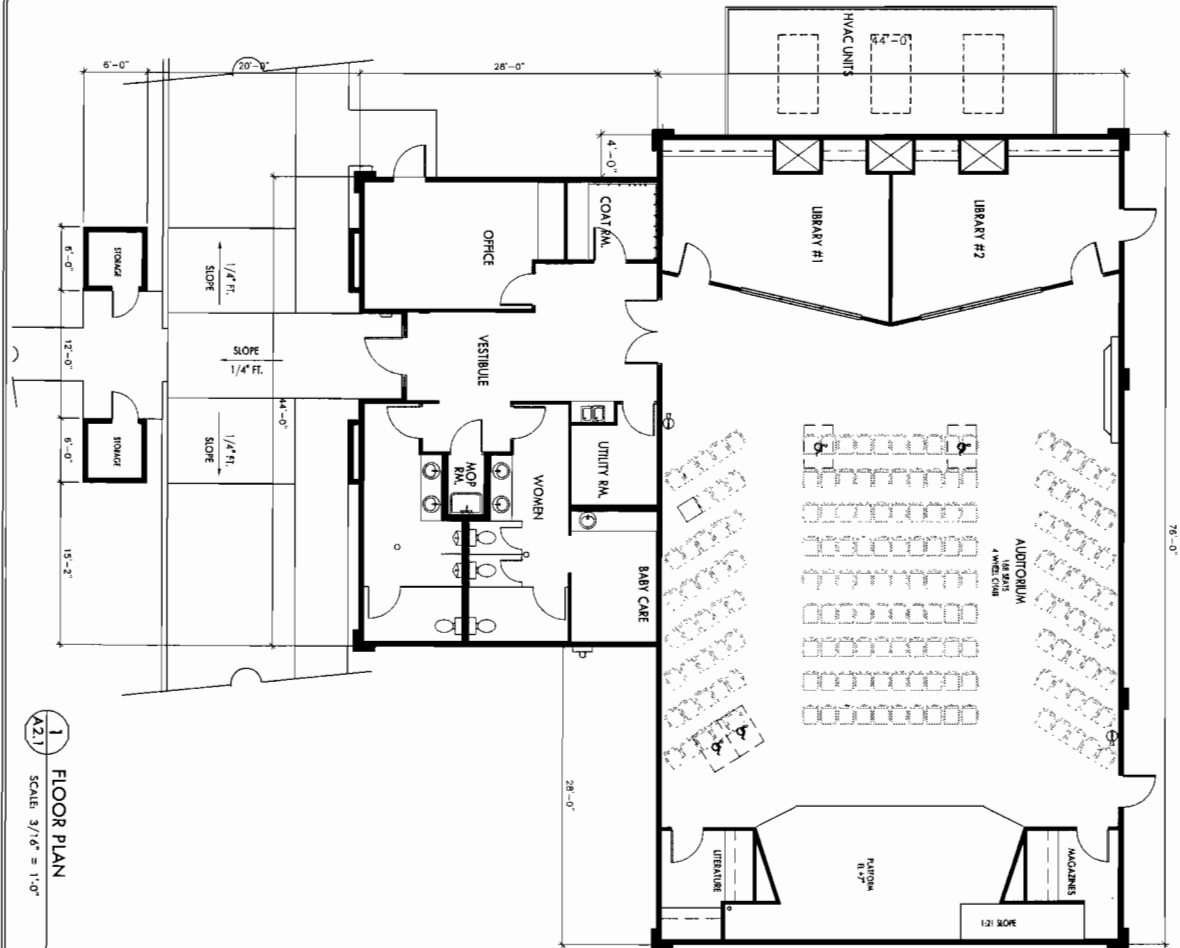

1 FLOOR PLAN  
 A2.1 SCALE 3/16" = 1'-0"

A2.1  
 SHEET NUMBER

REVISIONS:  
 PROJECT NUMBER:  
 DRAWN BY:  
 CHECKED BY:  
 ISSUE DATE:



SHEET TITLE:  
**FLOOR PLAN**

PROJECT TITLE:  
**GEORGETOWN KINGDOM HALL**  
 HWY 193 & RICCI ROAD  
 GEORGETOWN, CA

EXHIBIT J



SEP 10 11 00  
 UNCLASSIFIED  
 TRAINING DEPARTMENT

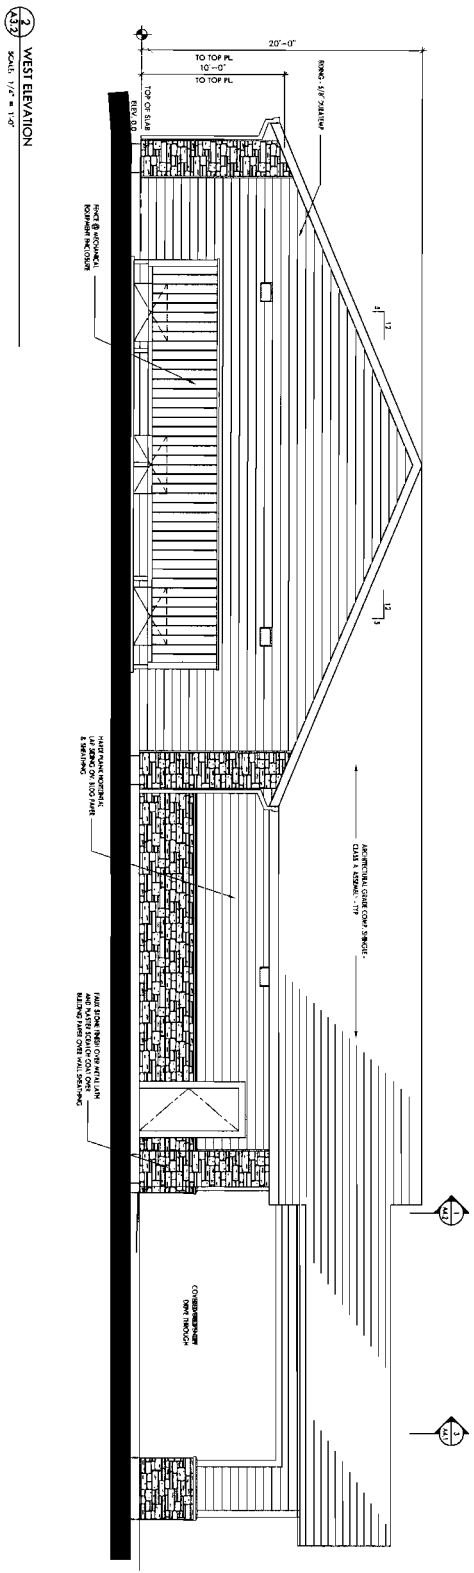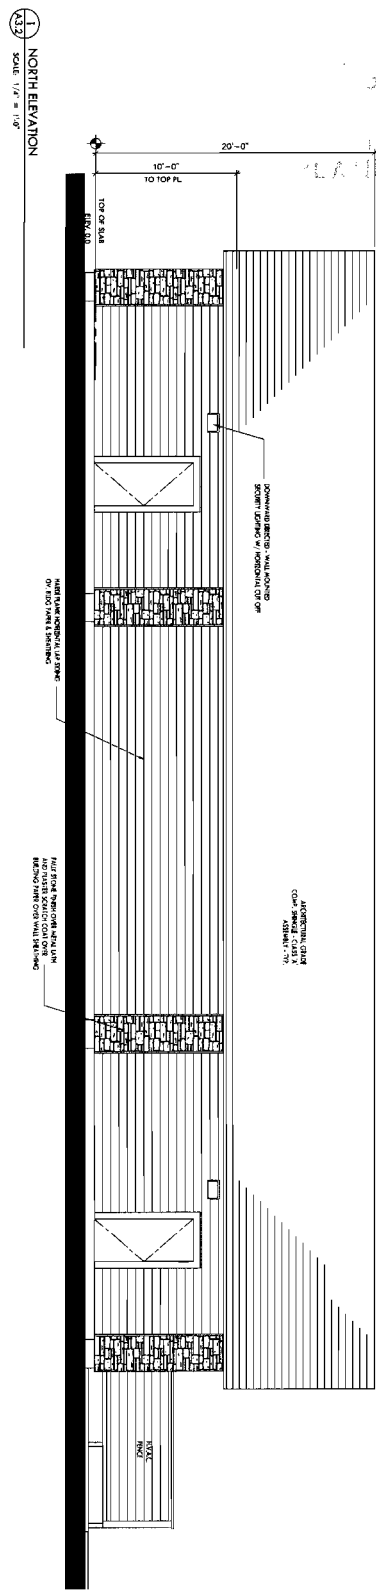


SHEET NUMBER <b>A3.2</b>	PROJECT TITLE: <b>GEORGETOWN KINGDOM HALL</b> HWY 193 & RICCI ROAD GREENWOOD, CALIFORNIA	
	SHEET TITLE: <b>EXTERIOR ELEVATIONS</b>	

# EXHIBIT L



The Sign Factory

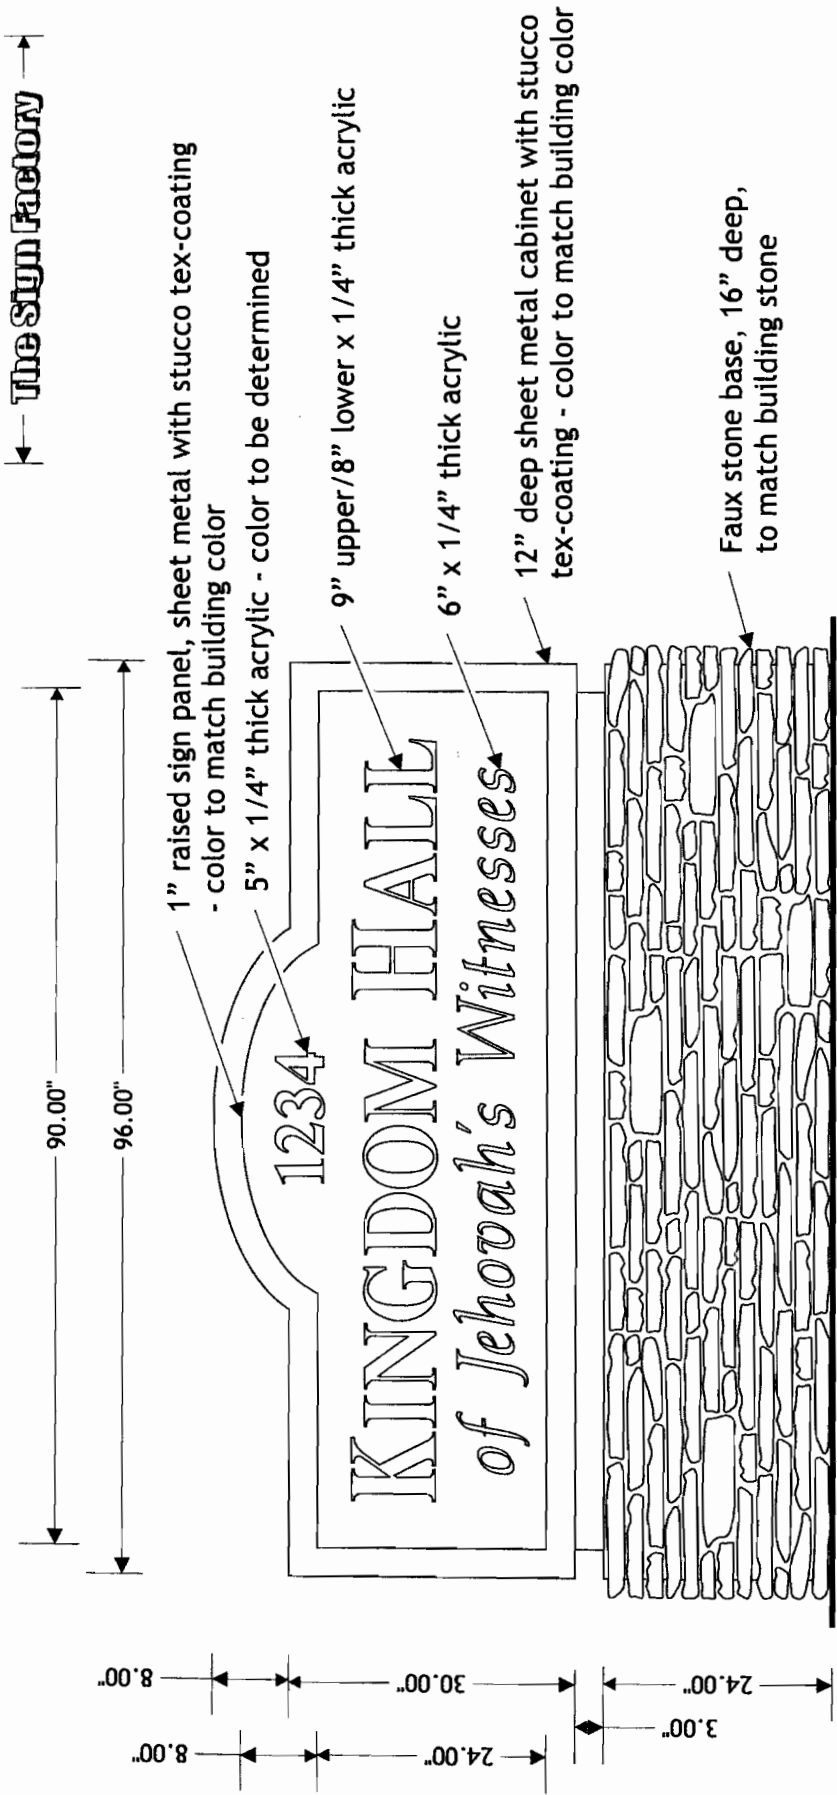

38" x 90" sign panel = 23.75 sq. Ft.

RECEIVED  
PLANNING DEPARTMENT  
SEP 23 2009

X

Approved - As Shown   
Approved - With Changes

All information on this page is copyrighted to The Sign Factory, Inc.

EXHIBIT M